



What: Ceiling Removal


Where: Corridor 390 & Corridor 392

Start Date: 11/23/2020

Impact: Limited user access during ceiling removal (see shaded areas)



Contacts:

- Vic Hoyecki – Project Superintendent – (203)943-2950
- Pam Buonocore – KGL Operations Manager – (203)915-4651
- Mark Veroneau – Yale Associate Project Manager – (475)241-2476

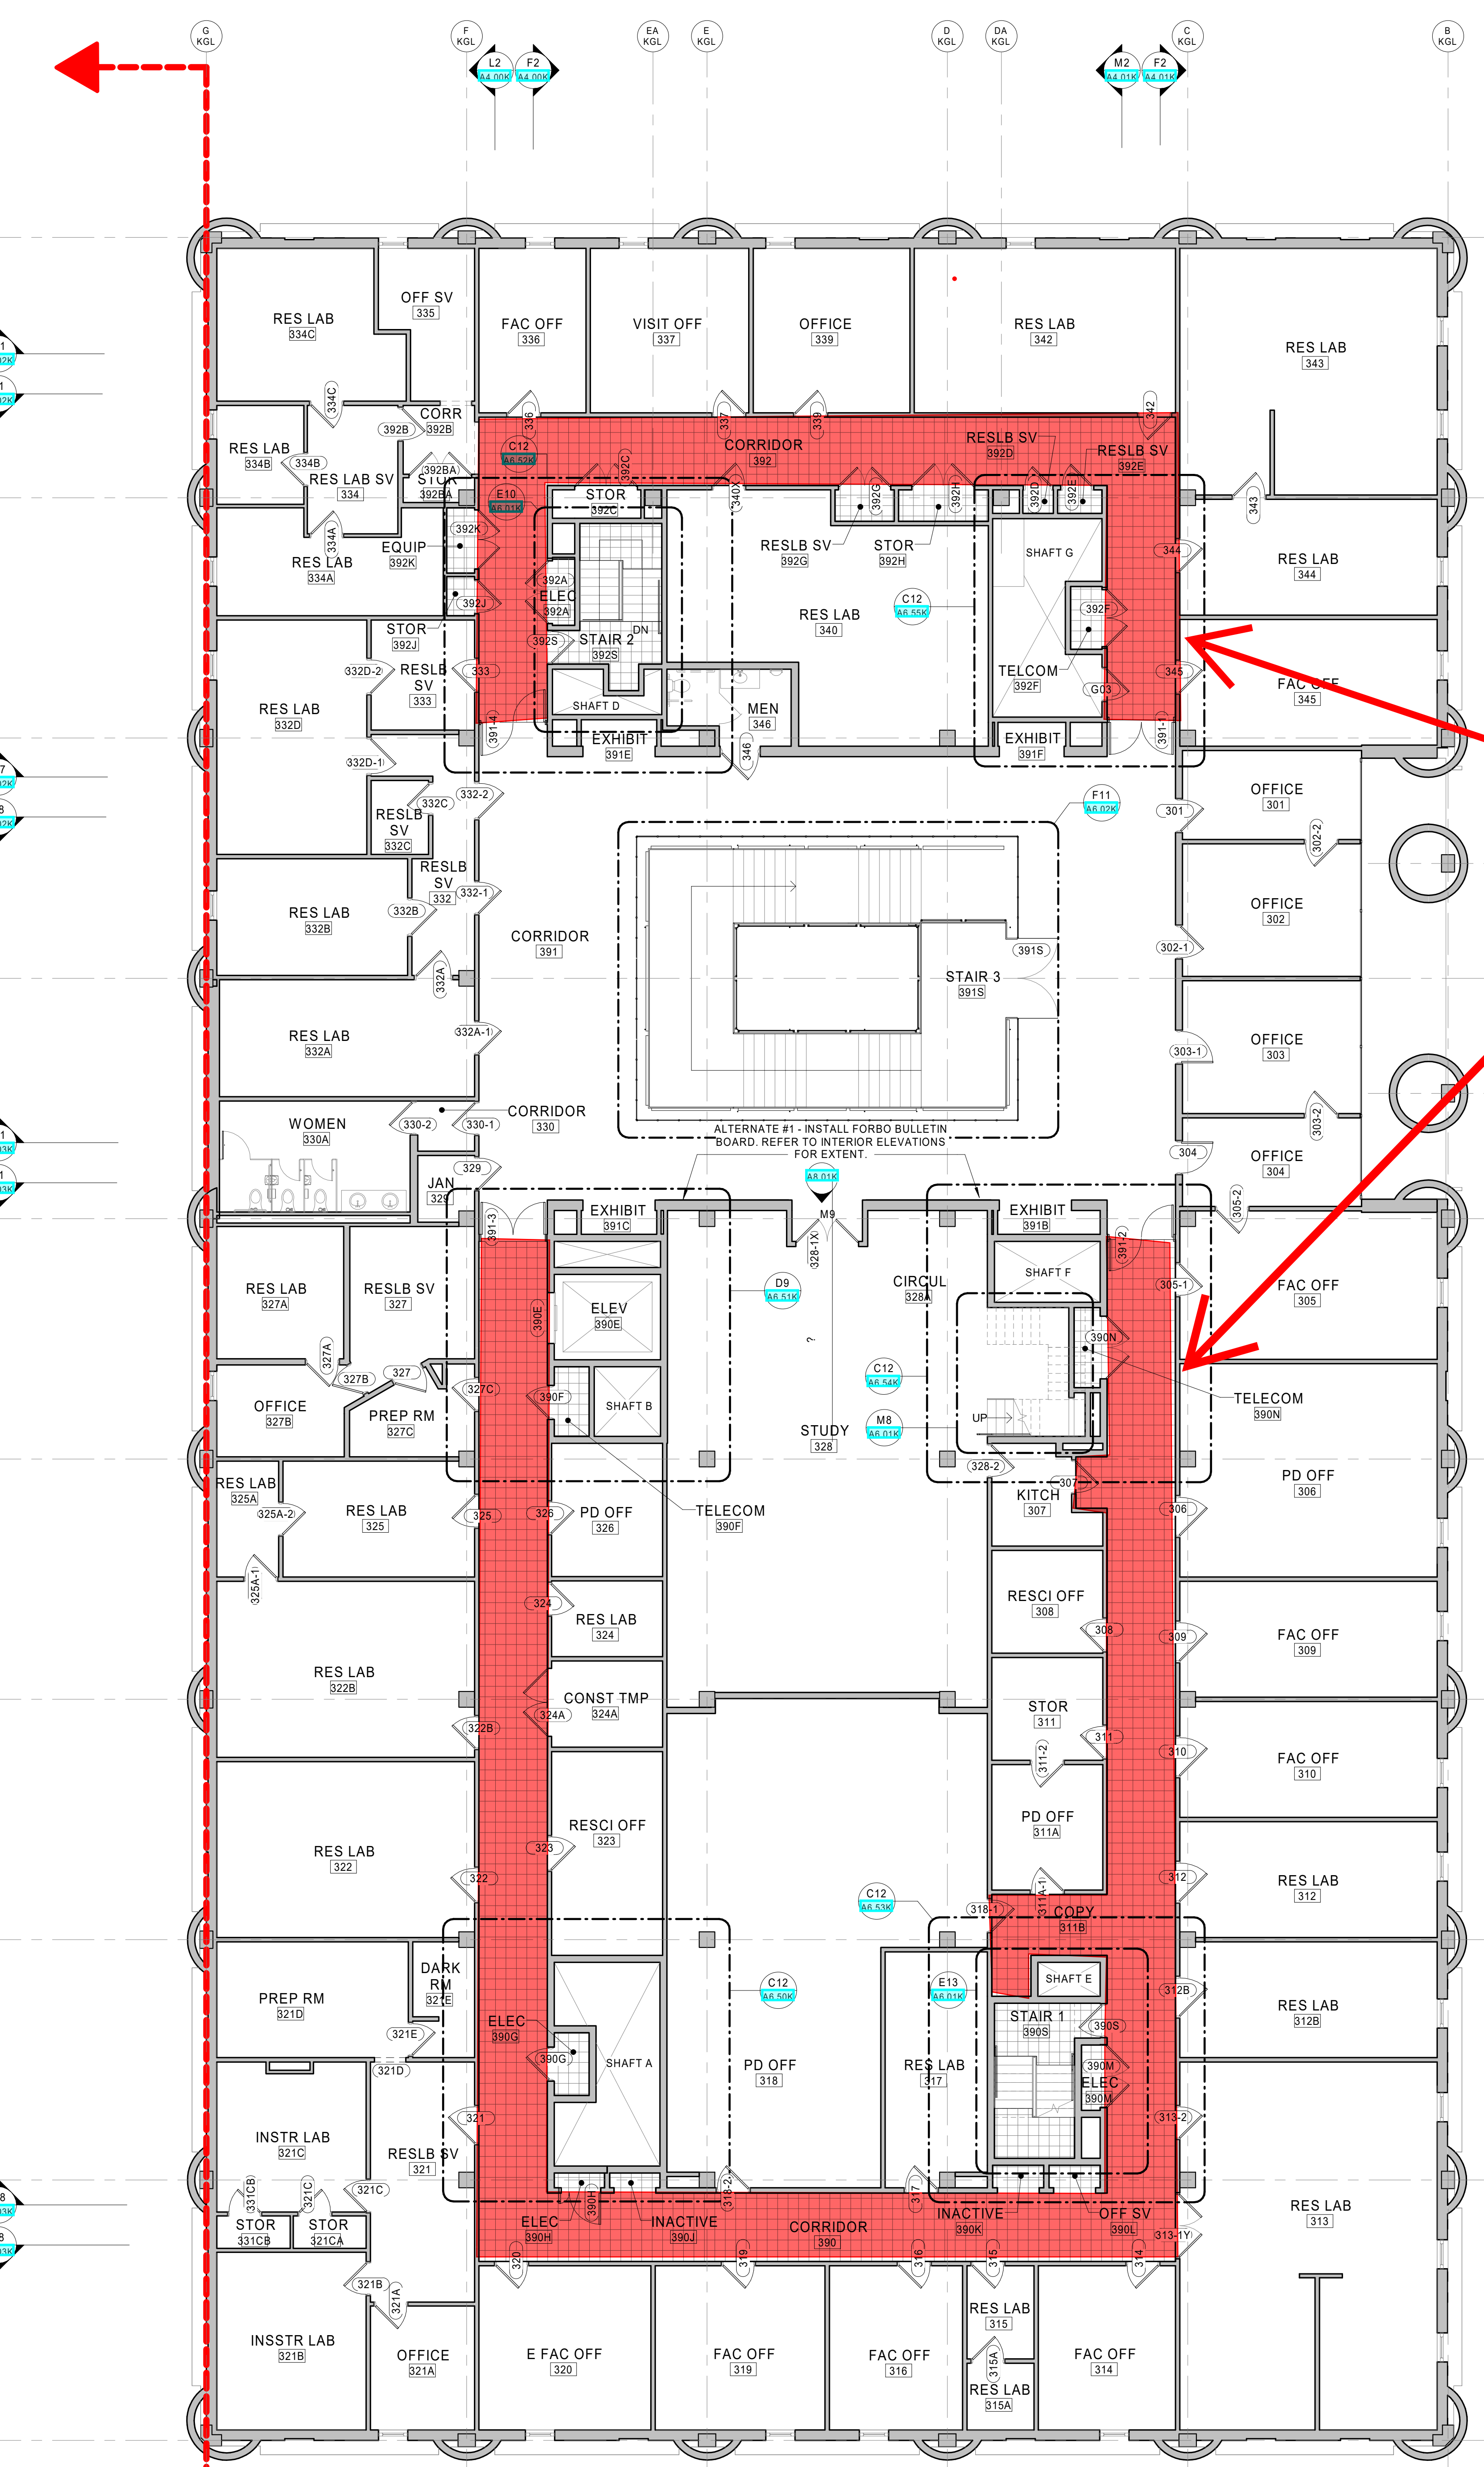

Corridor Ceiling Removal Start Date: 11/23/20

KGL 3rd Floor Corridor Ceiling Removal Work
Yale Kline Geology Laboratory Code Upgrades Project
New Haven, CT
Turner Project No. 201026
Data Date: November 6, 2020
By: VJH

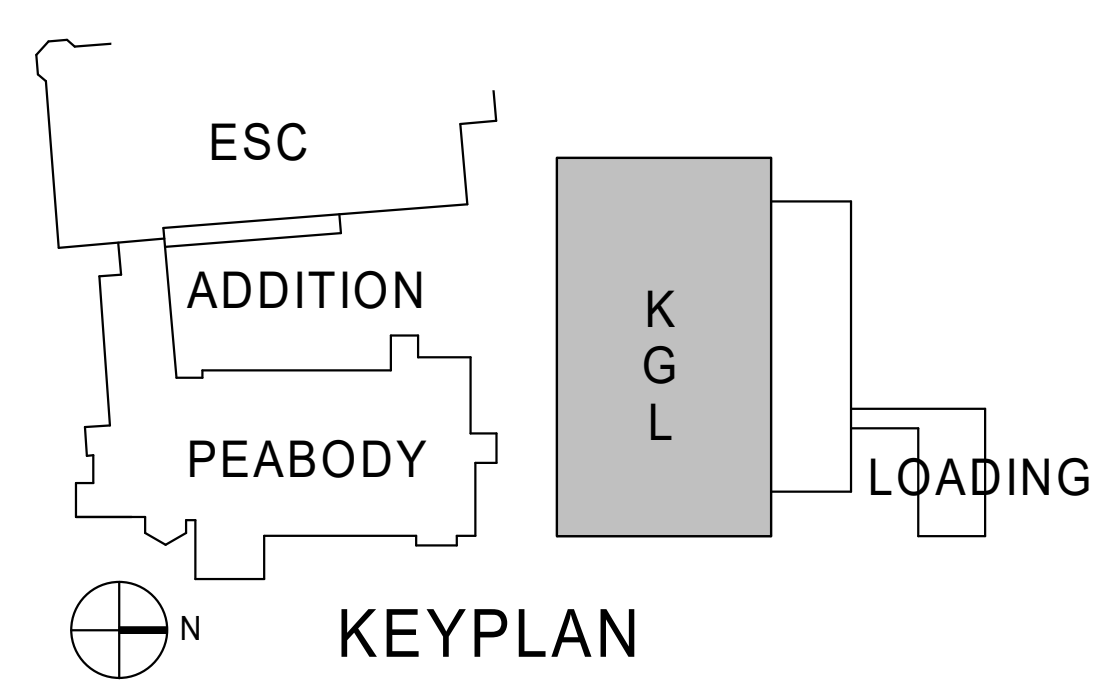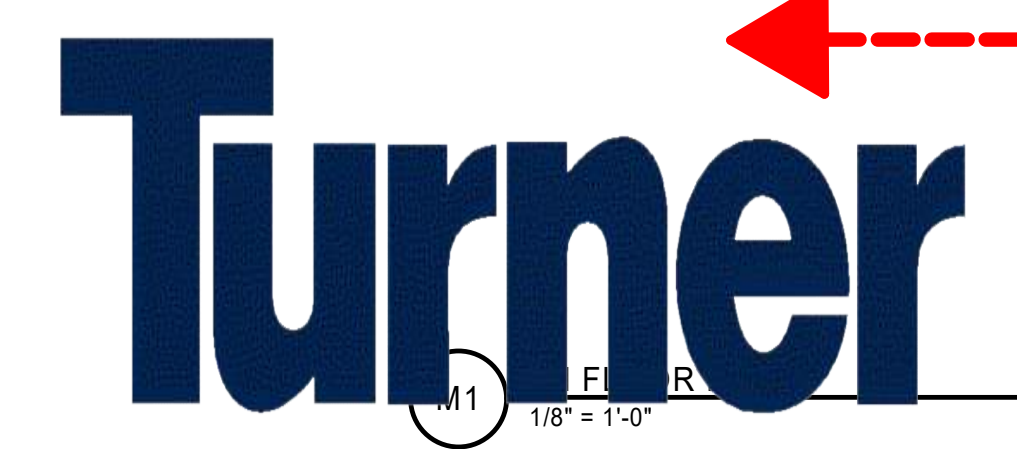

NO.	DATE	REVISION
NAME		
BID DOCUMENTS		
PROJECT NAME		
Yale Kline Geology Laboratory Code Upgrades		
BUILDING NAME & ADDRESS		
YALE KLINE GEOLOGY LABORATORY 216 WHITNEY AVE, NEW HAVEN, CT 06511		
PROJECT NUMBER		
17081006		
DRAWING TITLE		
THIRD FLOOR PLAN		
SCALE	DRAWN BY	
1/8" = 1'-0"	ECB	
CAD FILENAME	DATE	
17081006 A1.30K	6/12/2020	
DRAWING NUMBER		
A1.30K		

C:\p1\turner\201026\New KGL A1.30K.dwg, 6/12/2020 4:42:29 PM